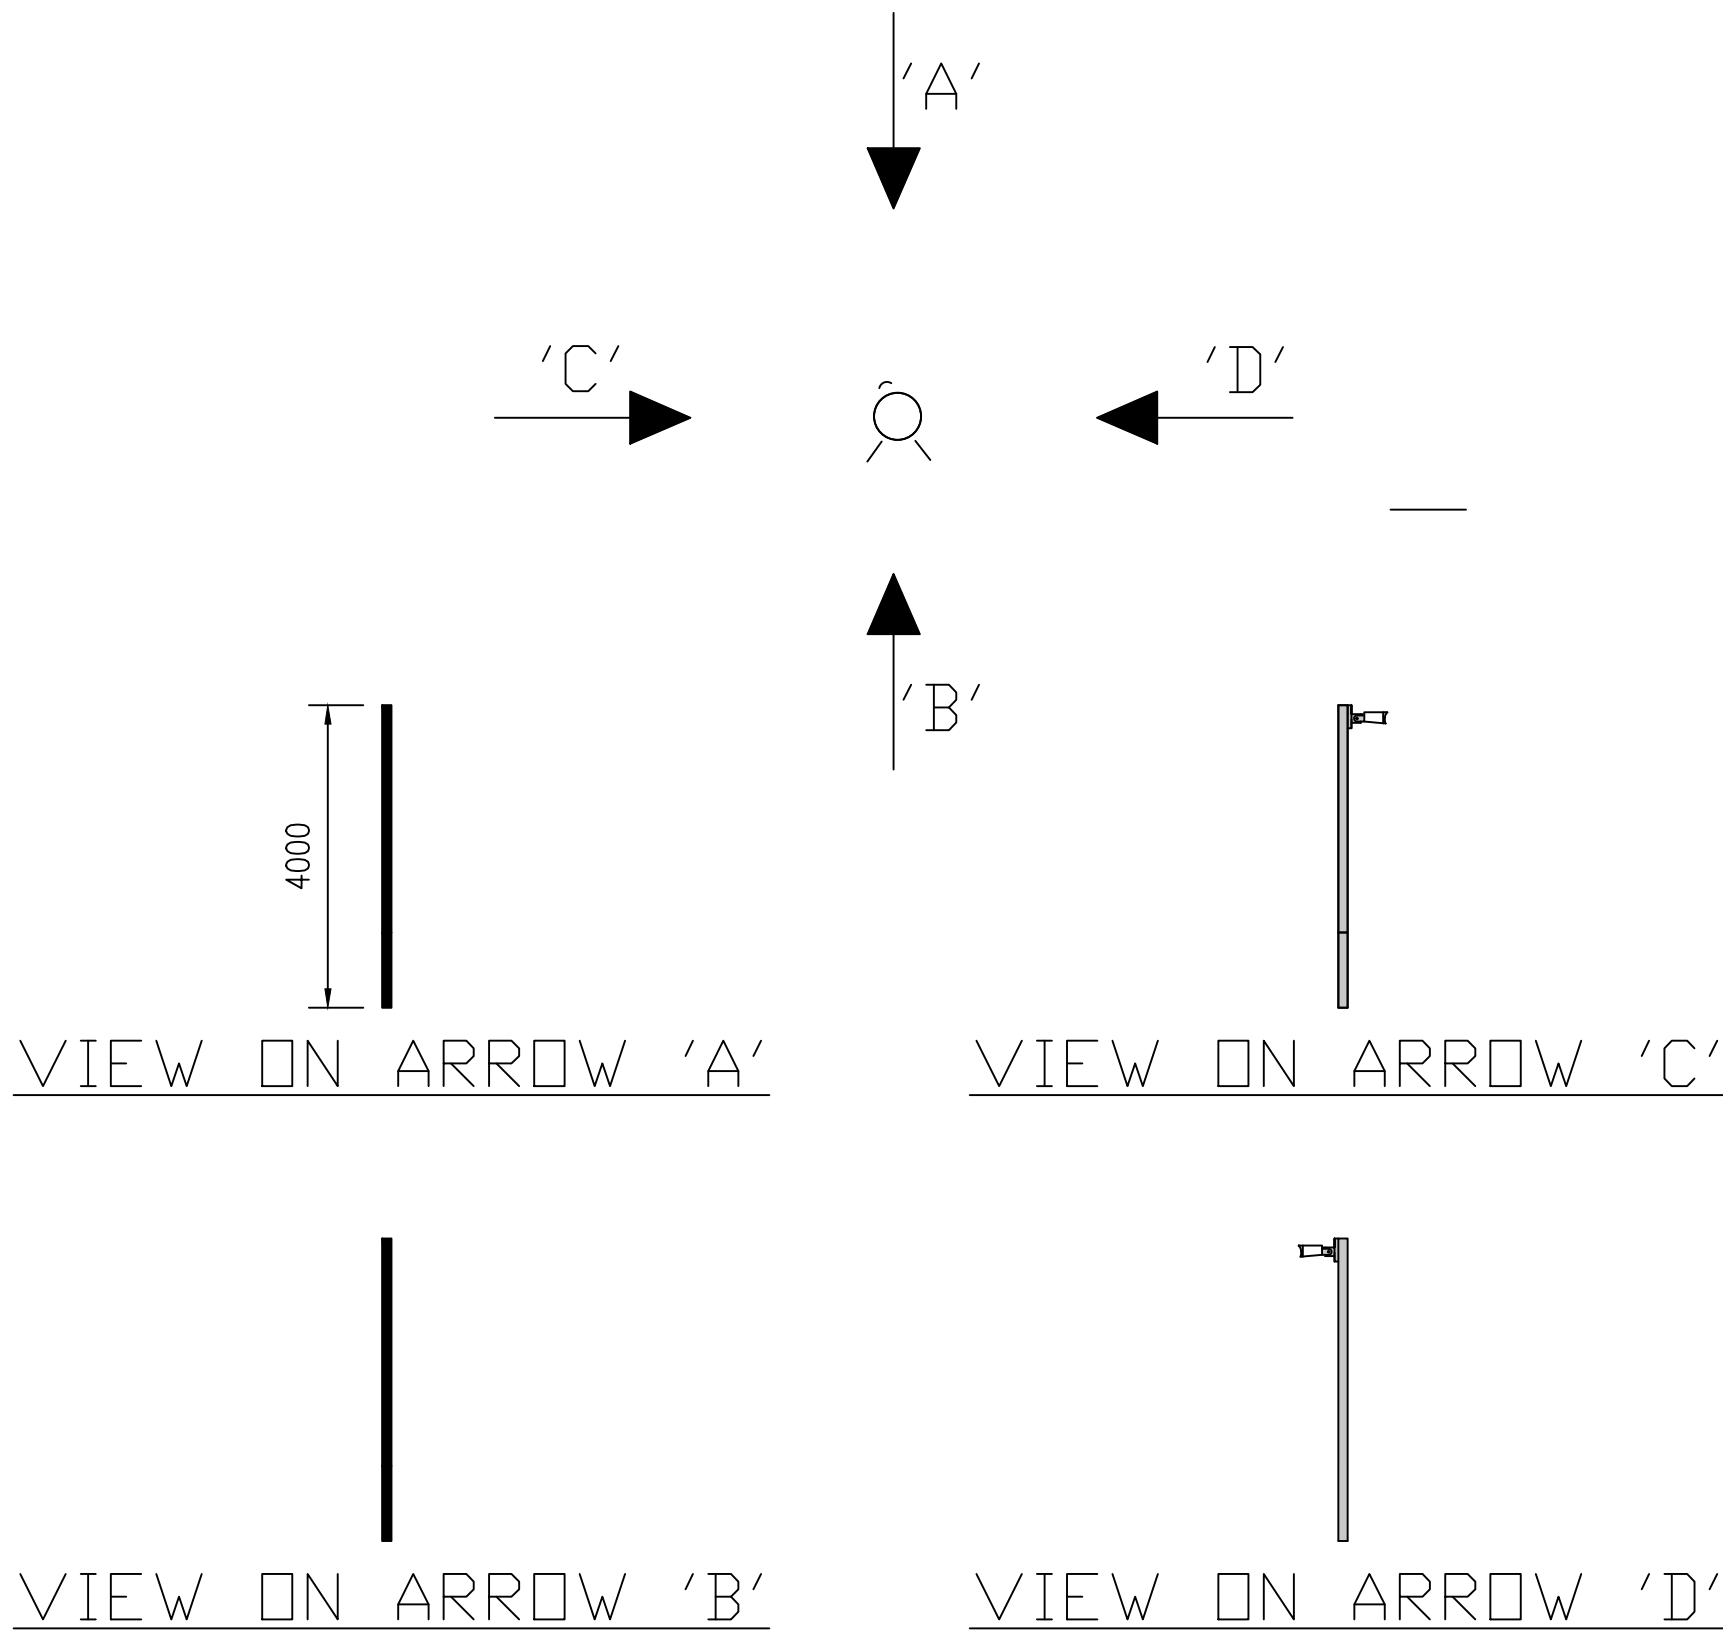


- NOTES:
1. DESIGN INTENDED FOR PLANNING PURPOSES ONLY. NOT FOR CONSTRUCTION.
 2. ANY DIMENSIONS SHOWN IN MILLIMETERS UNLESS NOTED OTHERWISE.
- Copyright © Harmony Energy Limited, 2024

 **HARMONY ENERGY**

Conyngham Hall
Knareborough
HG5 9AY

PROJECT: FLUSHING			
TITLE: CCTV PLAN			
SCALE: A3 @ 1:100	DATE: 05/02/2025	DRAWN: SW	CHECKED: HC
DRAWING NO: EQ_70_CCTV			REVISION: A